
 
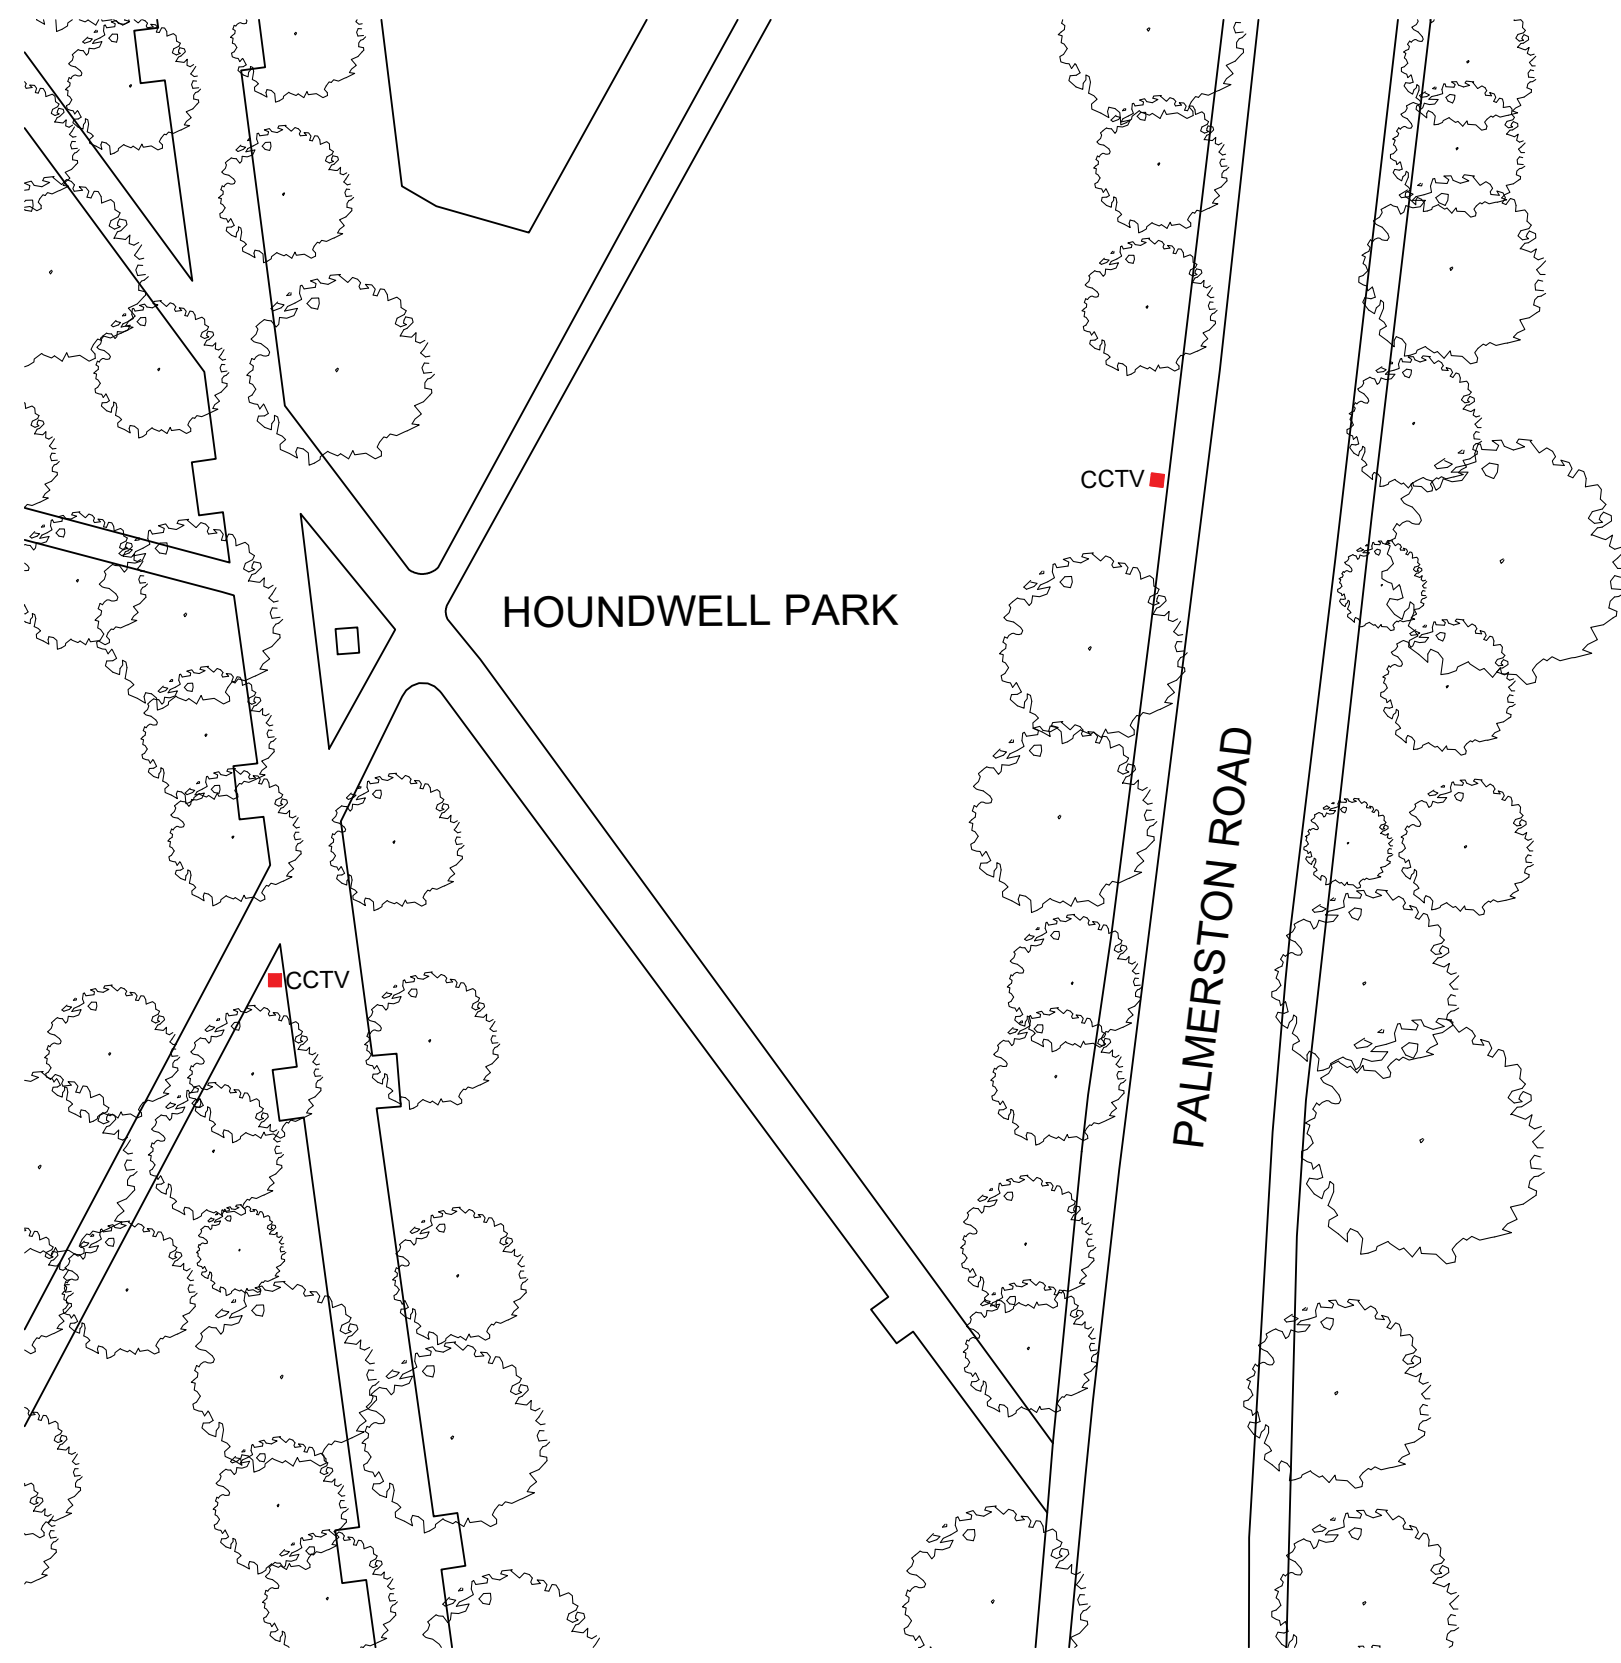



© COPYRIGHT Mace Group
 NOT TO BE REPRODUCED WITHOUT WRITTEN PERMISSION.
 BECAUSE OF POSSIBLE SCALING ERRORS IN ELECTRONIC
 AND HARDCOPY REPRODUCTION **DO NOT SCALE FOR
 CONSTRUCTION PURPOSES**. ALL DIMENSIONS TO BE
 CHECKED & VERIFIED ON SITE PRIOR TO CONSTRUCTION.



Location Plan @ 1:500

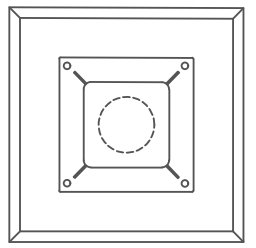

CCTV Plan (Not to scale)

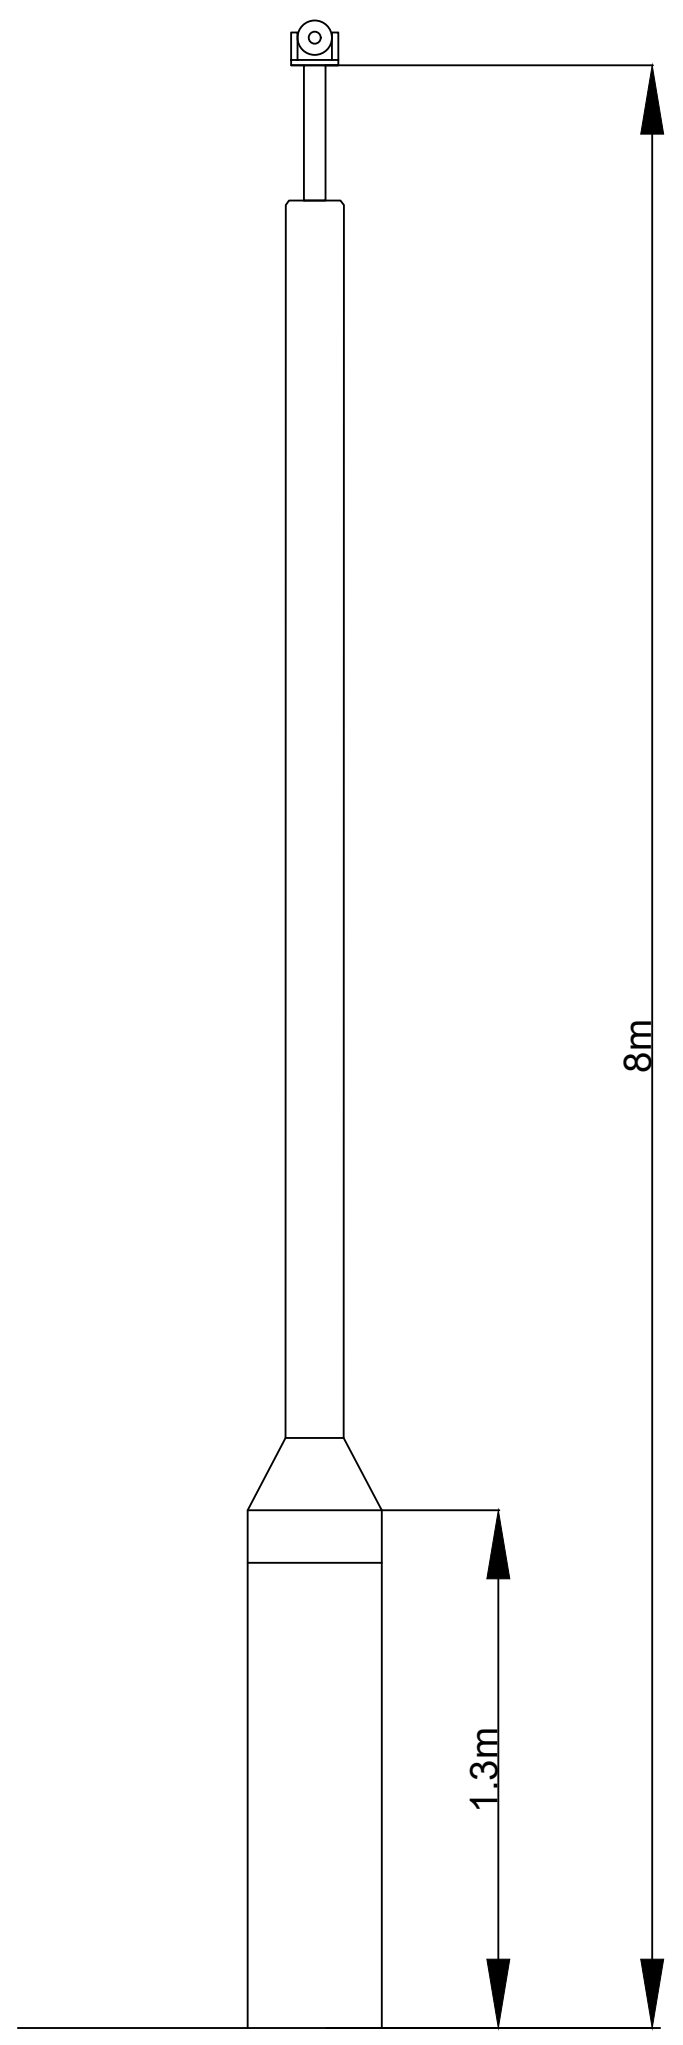

CCTV Front Elevation (Indicative, not to scale)

Rev	By	Description	Date	CHKD
				
<p>Mace Group</p> <p>Anglo St James House, 39a Southgate Street, Winchester, Hampshire SO23 9EH</p> <p>Telephone: +44 (0)20 3522 3000 www.macegroup.com</p>				
<p>PROJECT SAFER STREETS</p>				
<p>DRAWING TITLE HOUNDWELL PARK CCTV</p>				
DRAWN BY AD		DATE 02/12/2020		
CHECKED GB		SCALE 1:500 @ A3		
PROJECT No. XXXX	DISCI. Code A	SEQ. No. 13	REV. -	
<p>HCC ASSET CODE -</p> <p><small>FILED ON AUTOCAD AS-R:\Projects\Live\XXXX - Office of the Police and Crime Commissioner for Hampshire\Safer Streets\Design Team Folder\Architecture\Fencing\Fencing.dwg</small></p>				